

INFILTRATIEBEKKEN

OMHEINING SITE

KOOILADDER

KOOILADDER

B

BETON

LUCHTCOMPRESSOR
CONTAINER
14.79m²

GRIND

A

A

B

LEIDINGENBRUG

88.66m

445

606

111

150

-6.84m

= 0.00 : 0.00

LEGENDE BRANDWEER



Nooduitgang




 
Handbrandmelder



Brandblusser



Brandhaspel

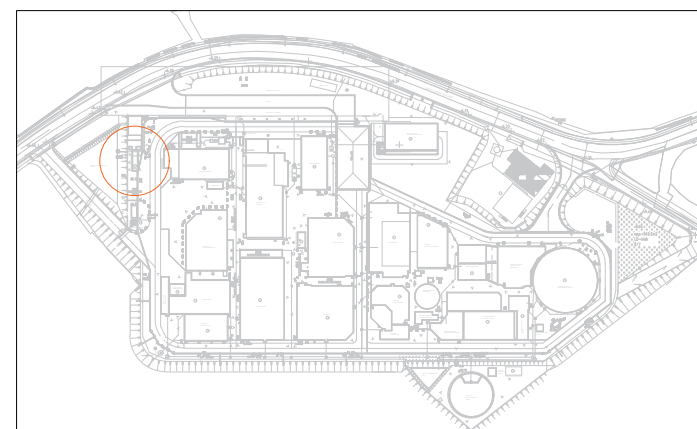

BA_LUCHTCOMPRESSOR_PB_BN_11
GRONDPLAN



schaal: 1/100
datum: 27-08-2024

