



LEGENDE BRANDWEER	
	Nooduitgang
	Handbrandmelder
	Brandblusser
	Brandhaspel

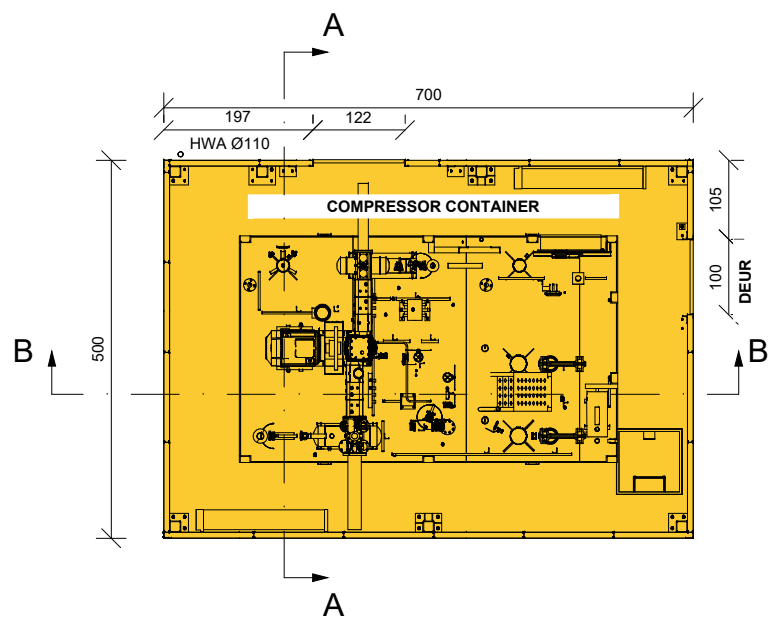

BA_COMPRESSOR CONTAINER_PB_BN_84
GRONDPLAN

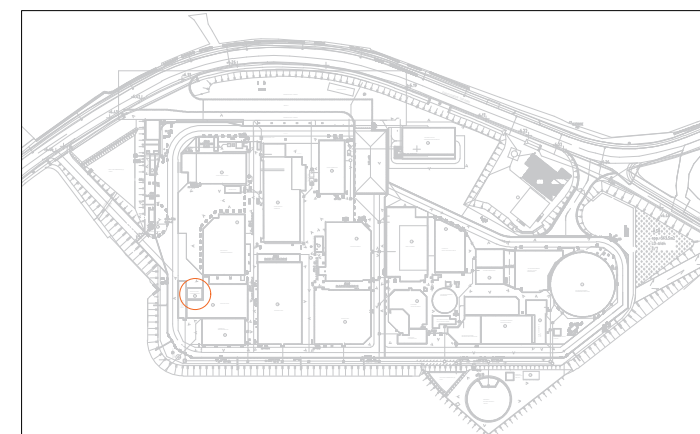

schaal: 1/100
datum: 28-08-2024

