
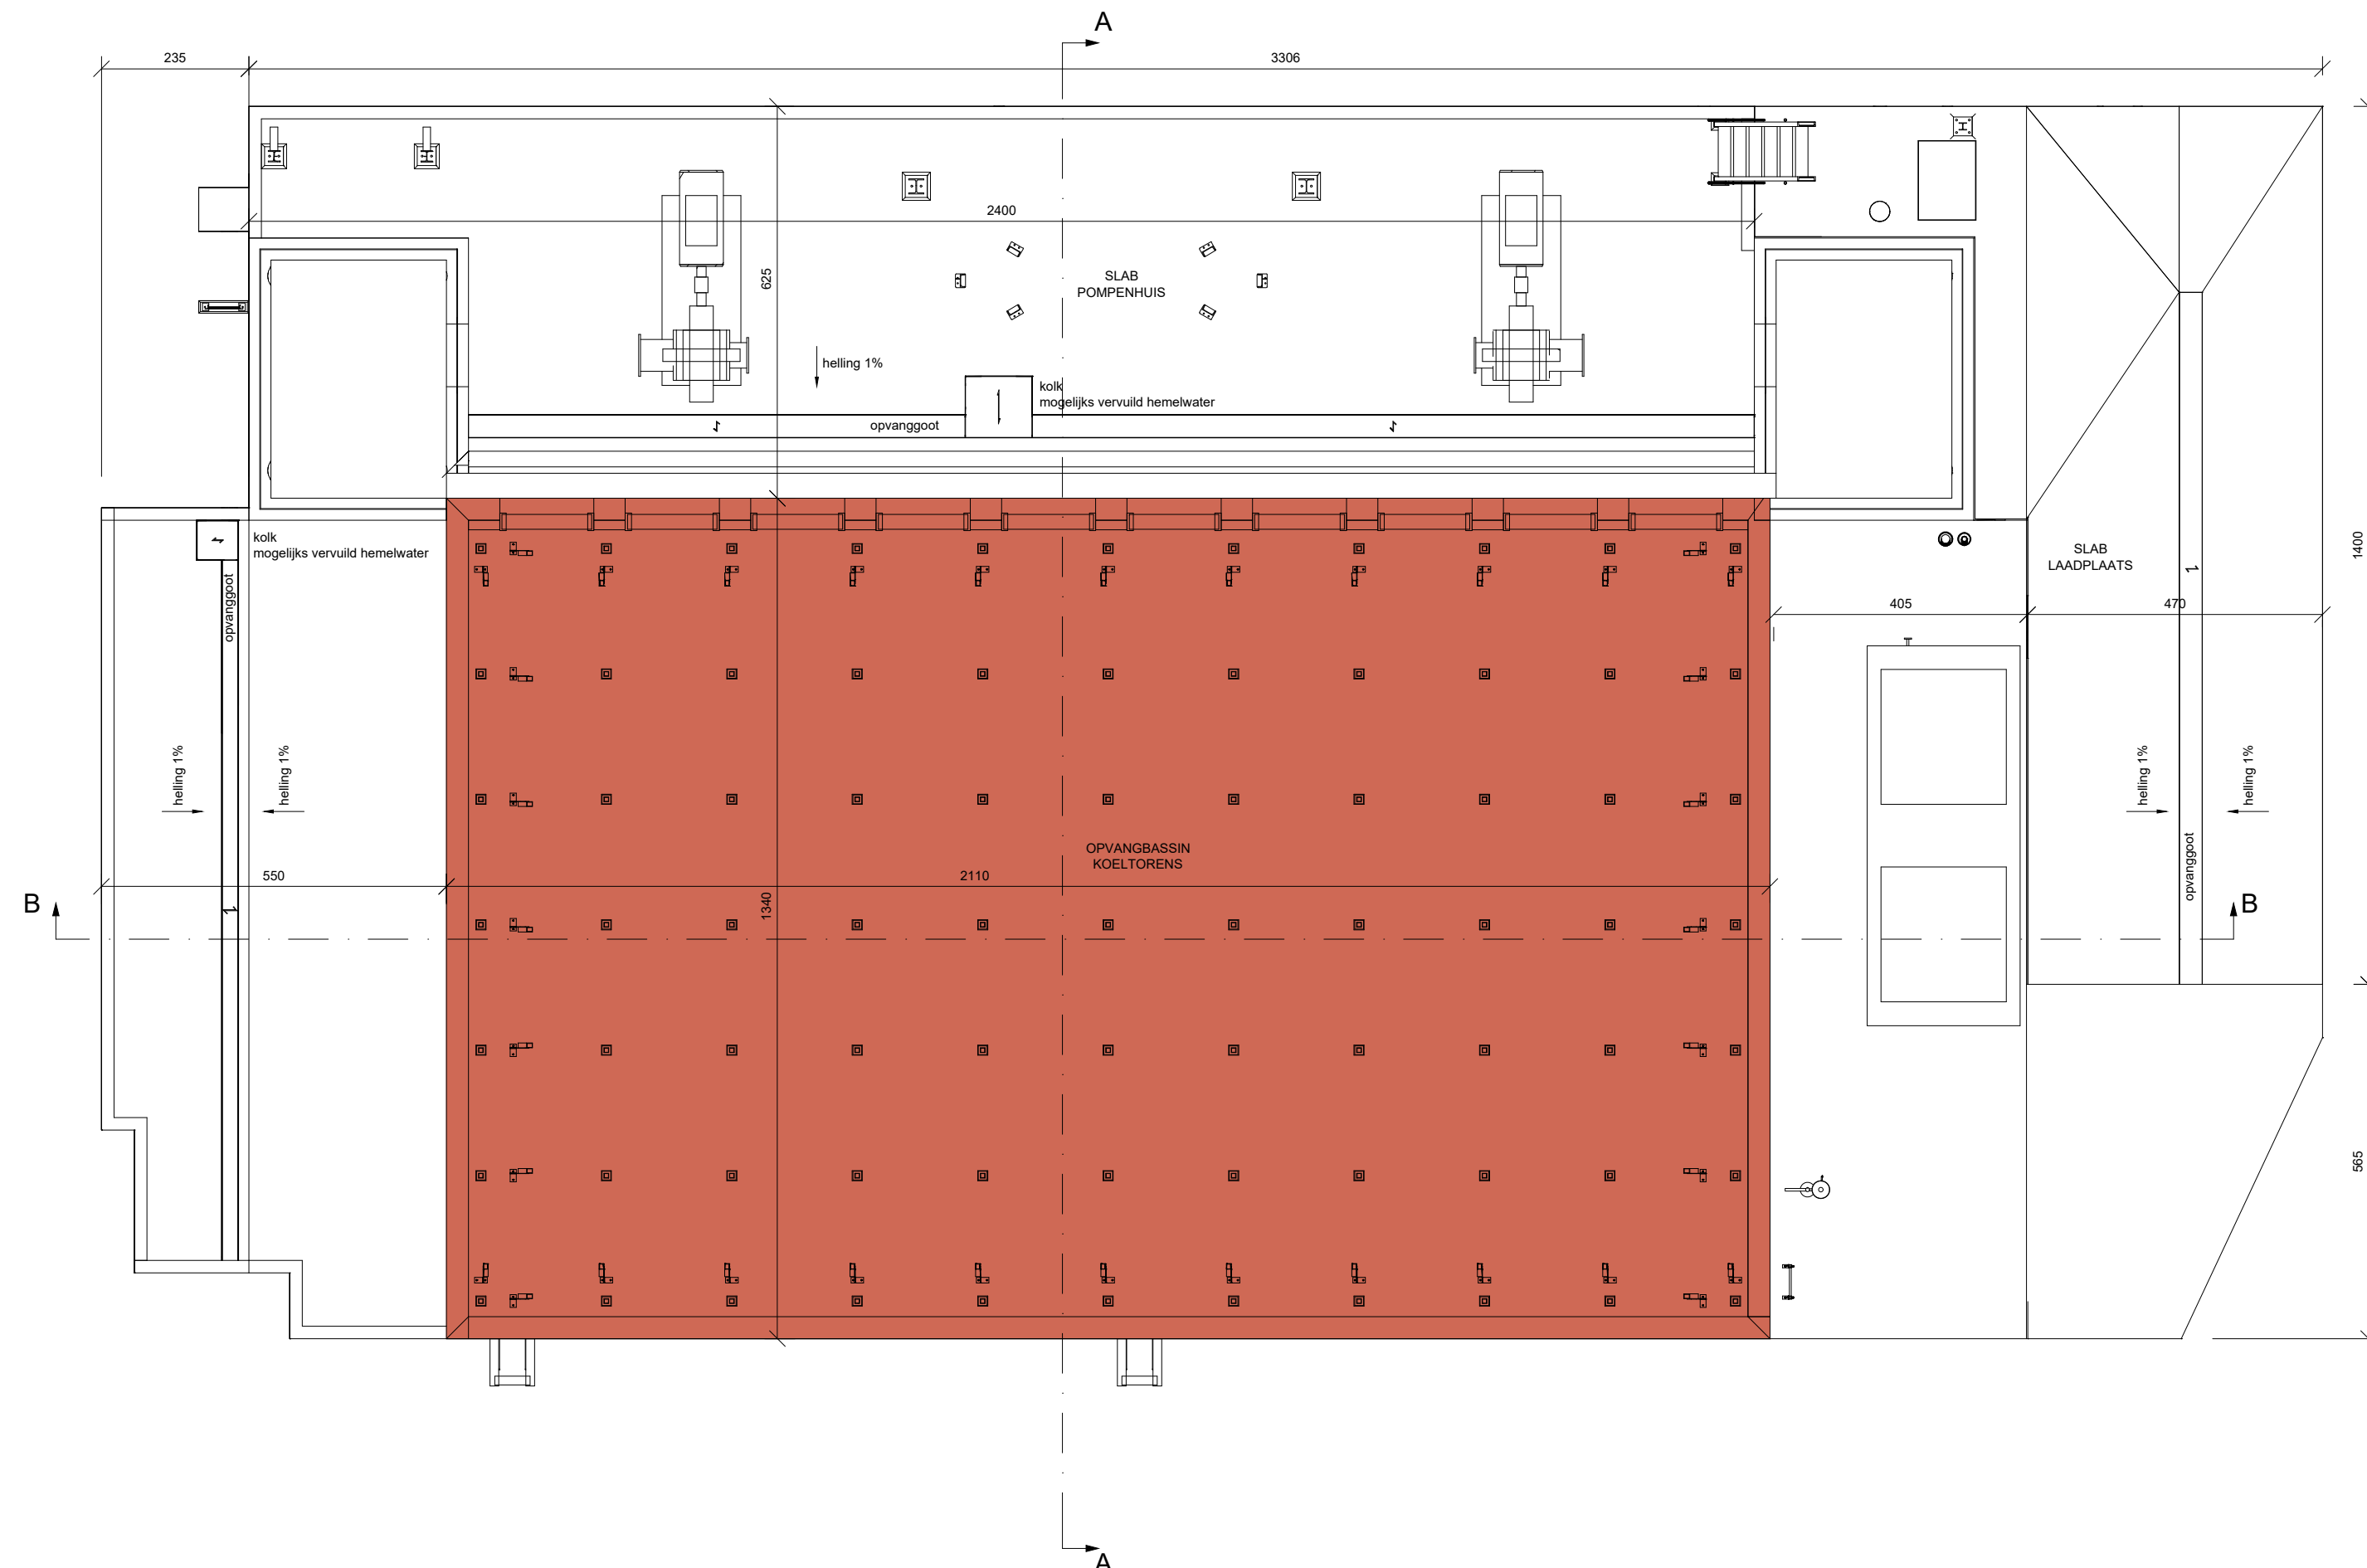


LEGENDE BRANDWEER	
	Nooduitgang
	Handbrandmelder
	Brandblusser
	Brandhaspel

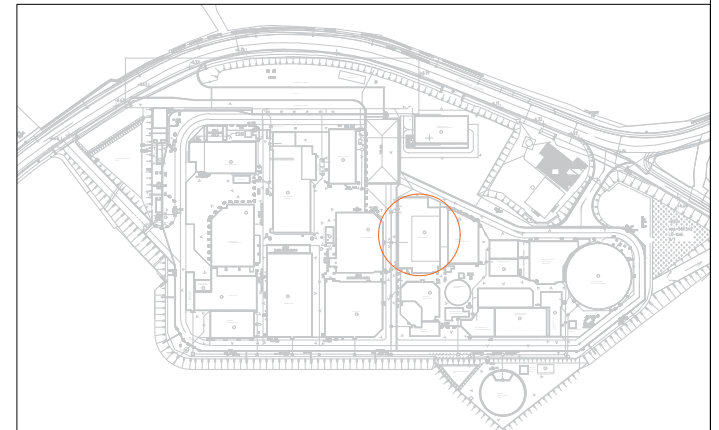

BA_KOELTOREN_PB_BN_162
GRONDPLAN

 **ALPHA**
STUDIES U.R.O. BV

schaal: 1/100
datum: 29-08-2024

