

 


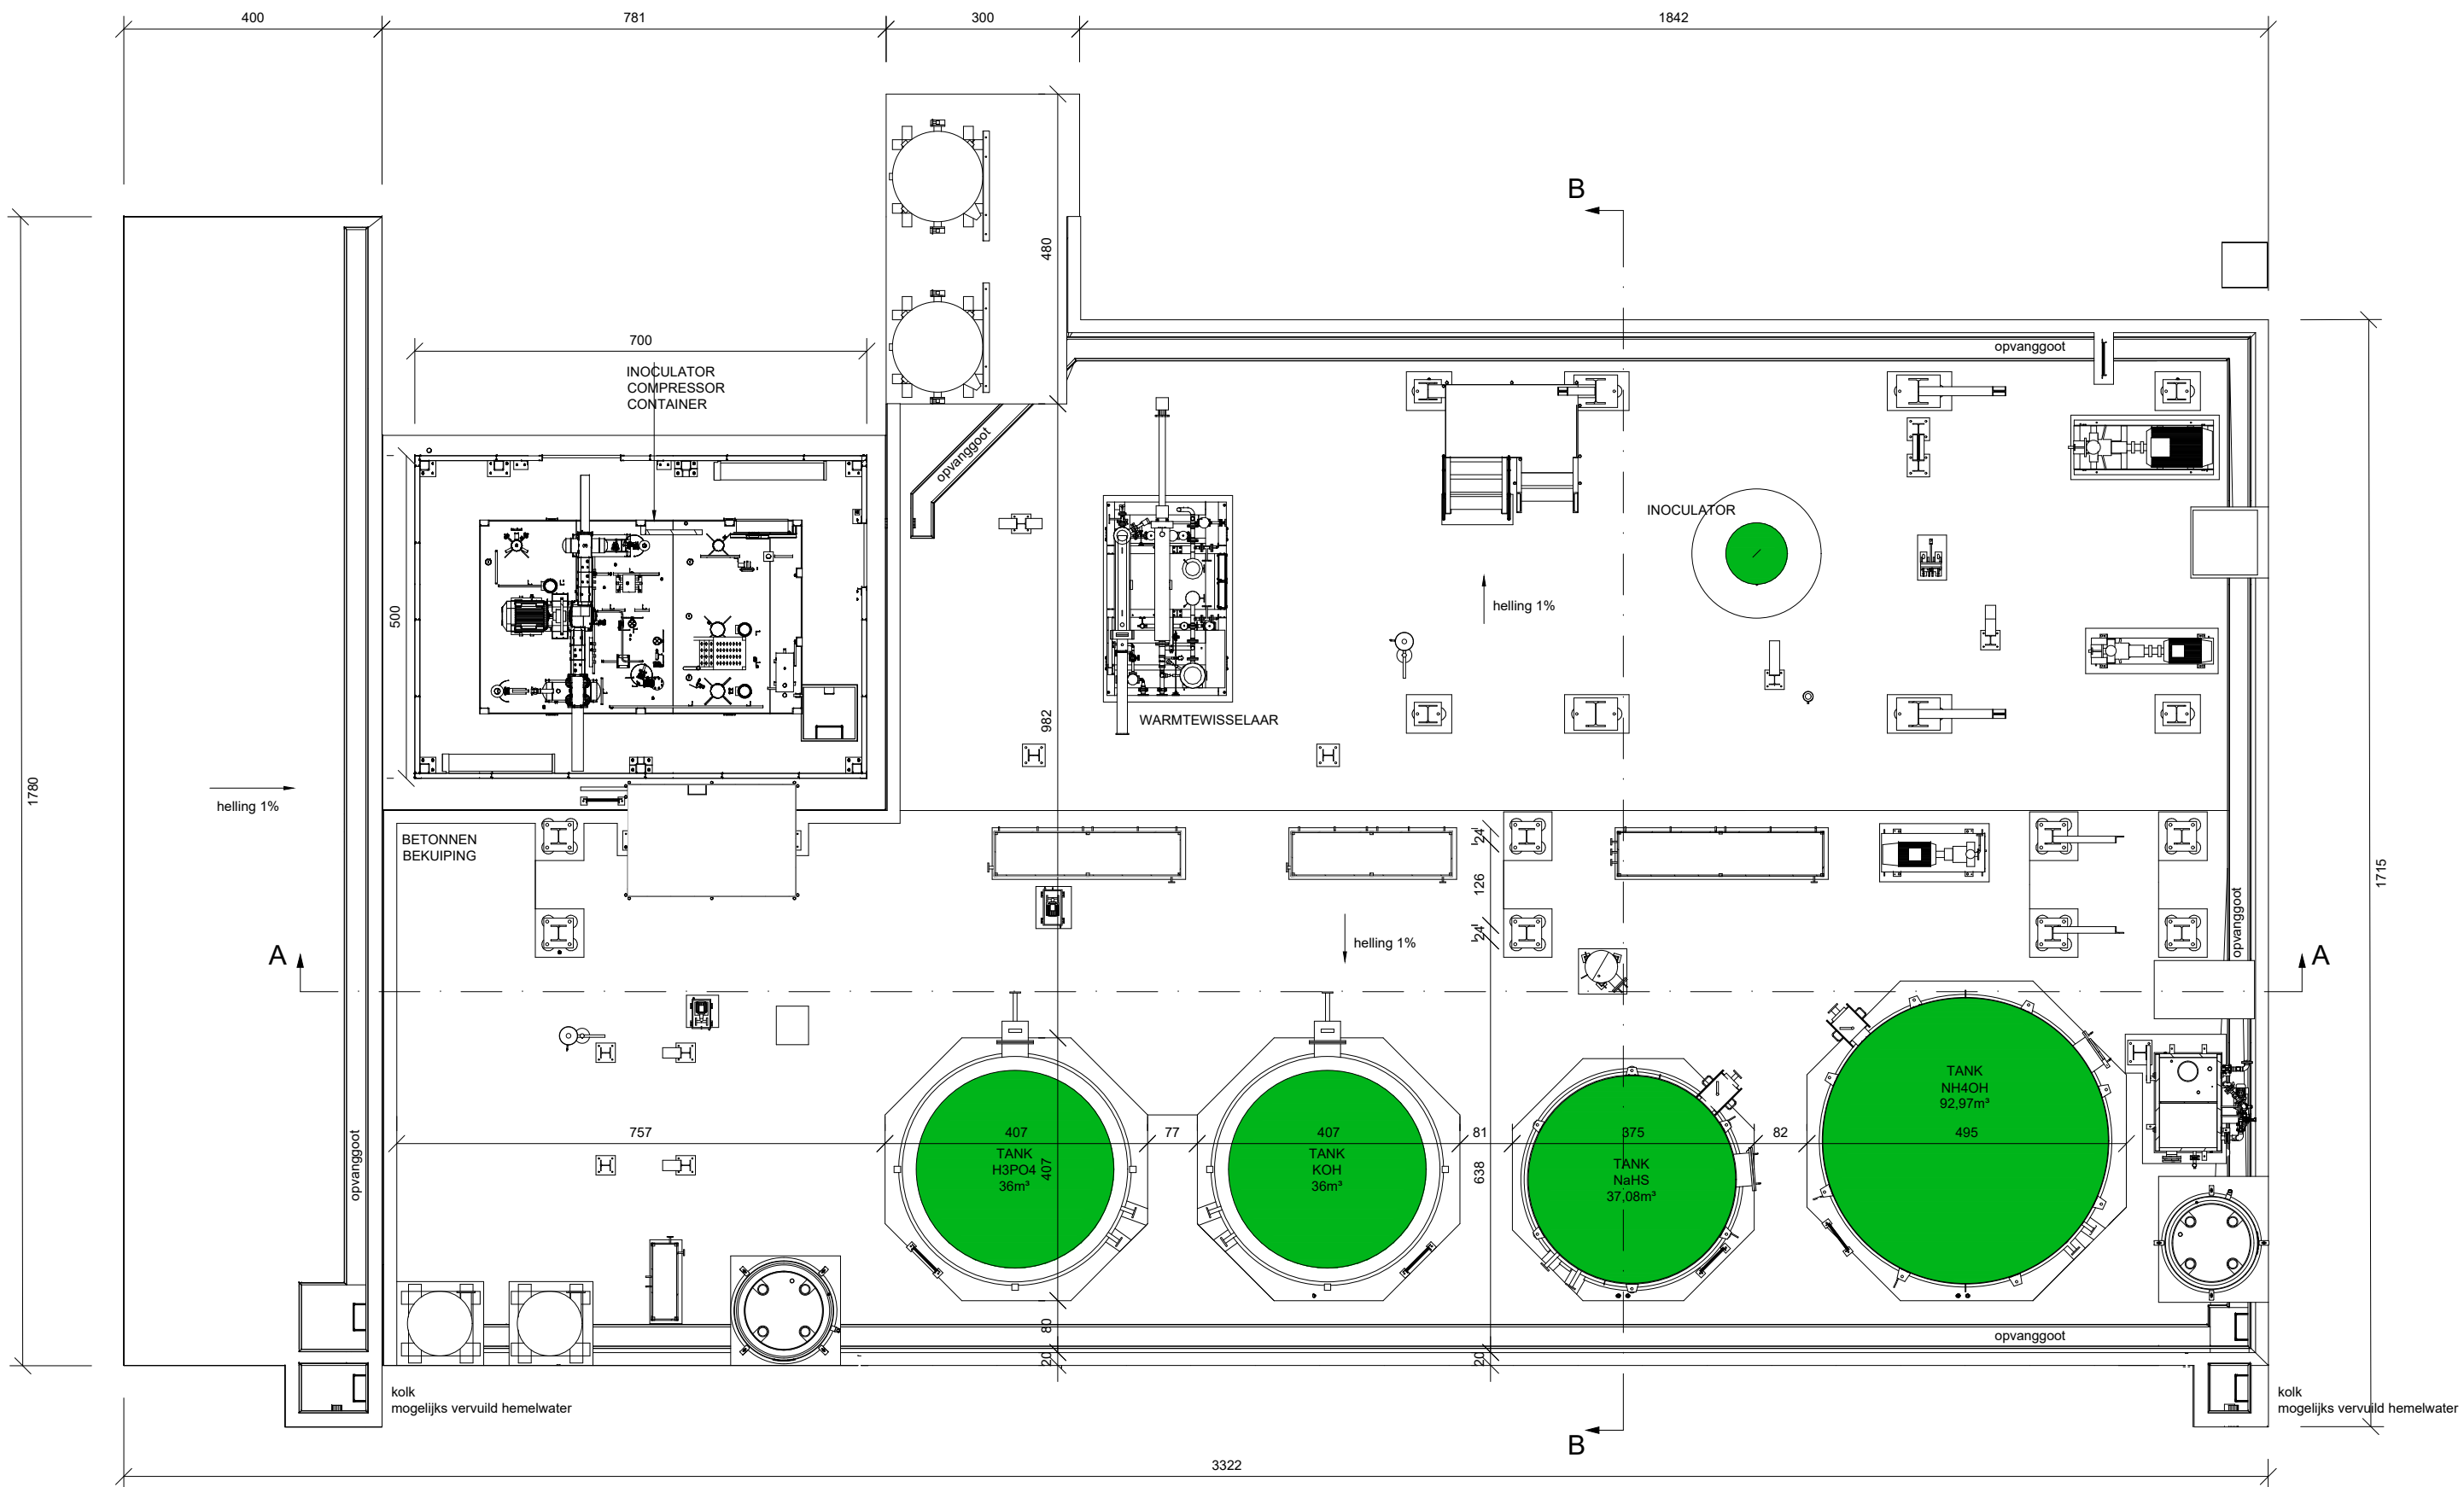

LEGENDE BRANDWEER	
	Nooduitgang
	Handbrandmelder
	Brandblusser
	Brandhaspel

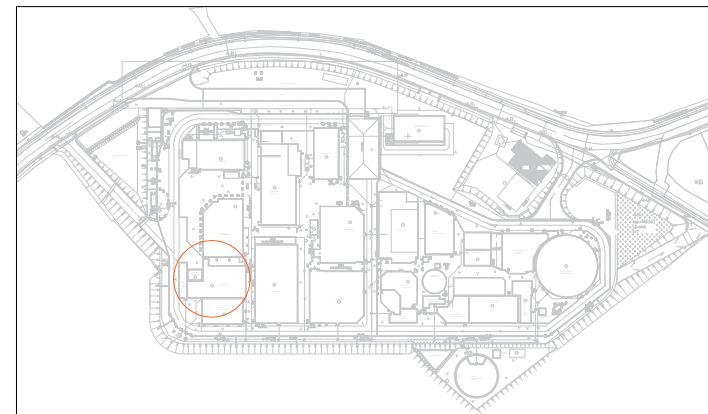

BA_INOCULATOR_PB_BN_186
GRONDPLAN



schaal: 1/100
datum: 29-08-2024

